



FIELD VERIFY EXACT LOCATION OF SUSP. BAFFLES AND LIGHTING TYPICAL.

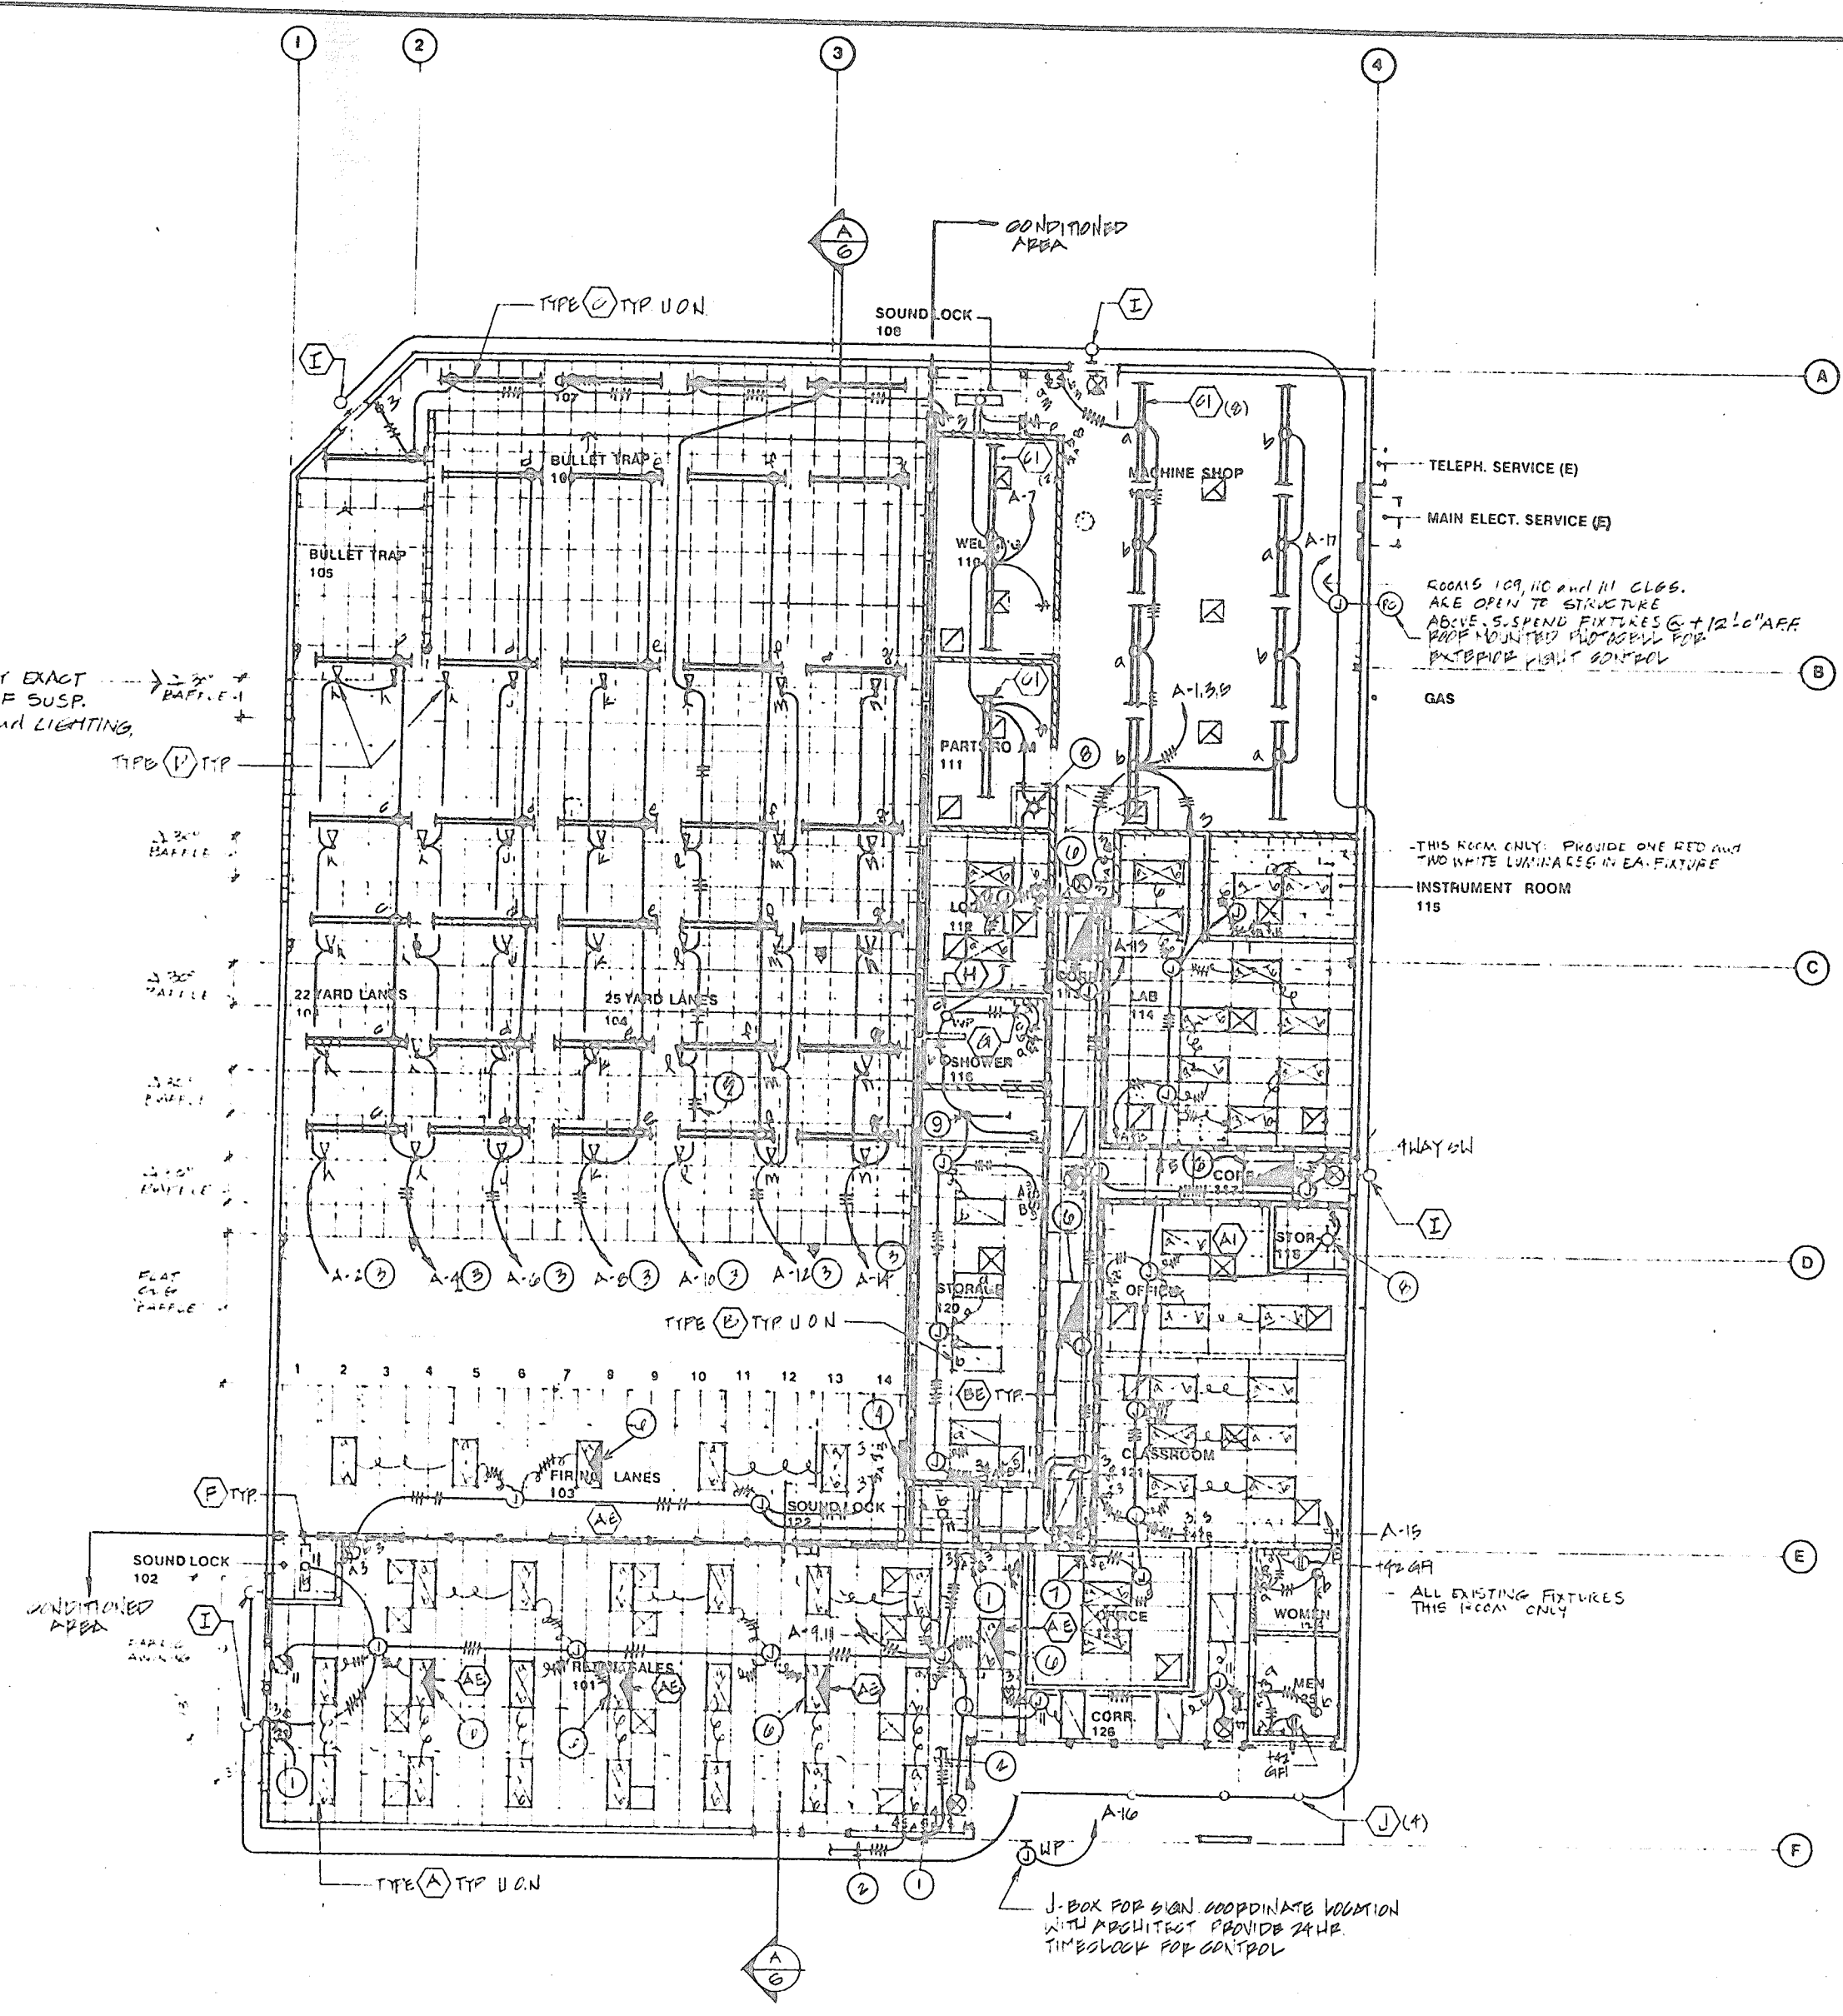

REFLECTED CLG. PLAN

SHEET NOTES

- 1 SWITCH 'a' CONNECTED TO CIRCUIT A-9, CONTROLS OUTBOARD LAMPS (150W LOAD). SWITCH 'b' CONNECTED TO CIRCUIT A-11, CONTROLS INBOARD LAMPS.
- 2 #10 TO NEXT SWAYT SWITCH BANK
- 3 CIRCUIT CONTROLLED BY SWITCH (ES) IN SWITCH BANK AS NOTED PROVIDE SWITCH LEADS AS REQUIRED.
- 4 FILING LANE LIGHTING SWITCH BANK LOCATION SEE ELEVATION THIS SHEET.
- 5 EXTEND CIRCUIT A-10 TO LIGHTS IN CORRIDOR 107
- 6 CONNECT EMERGENCY EXIT BATTERY PACK (INBOARD LAMP ON 3 LAMP FIXTURE) TO UNBATTERED CIRCUIT LEAD.
- 7 NUMBER LIGHTING CONTROL OVERRIDE SEE DIAGRAM SLIT B-2
- 8 PROVIDE LAMP HOLDER WITH FULL GAIN
- 9 4 FT 2 LAMP FLUORESCENT STRIP, DAY-BRITE # T-240-120-ES W/ FAULT/TEST LAMPS.

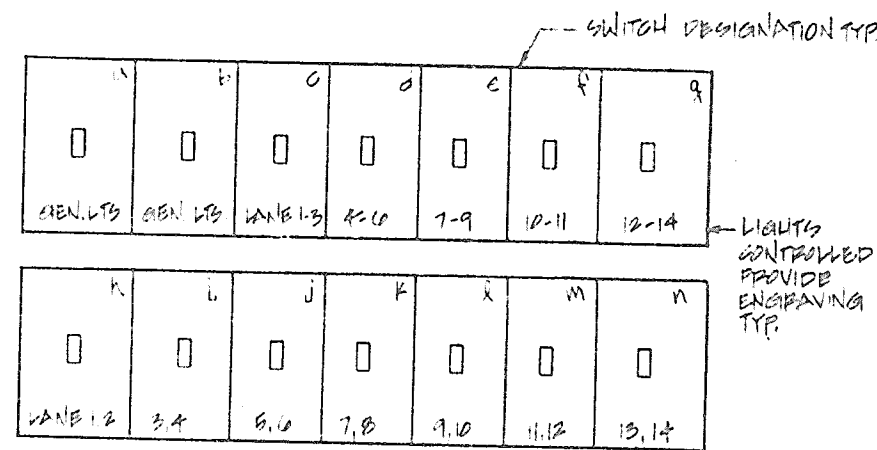

FILING LANE SWITCH BANK ELEVATION
N.T.S.

- 2' TYPE SUSPENDED FLUOR. LIGHT FIXTURE
- ◁ SURFACE MTD. INCAND. SPOTLIGHT 150W LAMP
- ▭ 2'-0" x 4'-0" SUSPENDED ACOUSTIC CEILING TILE GRID SYSTEM
- ▭ 5/8" TYPE 'V' GYP BR. CEILING ON FRAMING, MIN. 2' x 4' @ 24" O.C. TO E. W.R. @ 12" TYP.
- ▭ 2'-0" x 4'-0" RECESSED FLUORESCENT LIGHT FIXTURE, 3 LUMINAIRES EA. BOX IN @ THE LOCATIONS, CORR # 113 AND 117
- ▭ 1' x 4' SURFACE MTD. FLUOR. LIGHT FIXTURE
- ▭ 2' WALL MTD. FLUOR. FIXT.
- WALL MTD. INCAND. (EXTERIOR NO)
- RECESSED INCAND. LIGHT FIXTURE (N.B. NATHANSON)
- PENDANT INCANDESCENT
- EXHAUST FAN - SEE MECH. DRAWINGS
- ▭ SUPPLY AIR GRILL - SEE MECH.
- ▭ RELIEF REGISTER
- ▭ RETURN AIR GRILL - SEE MECH.
- ▭ EXIST. 4' x 8' SKYLIGHTS TO REMAIN (5 TOTAL)
- EXIST. TURETINE ROOF VENTS TO REMAIN (4 TOTAL)
- ▭ EXIST. ROOF ACCESS, PROVIDE ACCESS THRU SLO. OF ROOM # 121 WITH FRAMED PLATFORM AND LADDER (SEE IN LAGE REGR.) TO ROOF.
- ▭ DIRECTIONAL EXIT SIGN


LEGEND (SEE LUMINAIRE SCHEDULES SHEET B-8)

REVISIONS	BY

GARY B. BAKER ARCHITECT
 8400 MISSION BLVD., SUITE 200
 SAN DIEGO, CA 92161
 619-591-1111

ACCURACYGUN
 7318 Wilkerson Ct., San Diego, CA 92123

DESIGN DEVELOP.	DATE	1-22-94
PLAN CHECK	SCALE	1/8"=1'-0"
BIDDING	DRAWN	MLP
CONSTRUCTION	JOB	300B
RECORD	SHEET	F.4
OF 28 SHEETS		

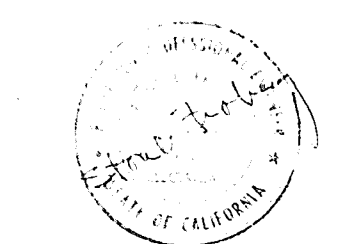

ILA ENGINEERING
 47 Rufus Road, Suite G, San Diego, CA 92108
 Tel: 619-591-0140 Fax: 619-591-0141